



FLOOR PLAN
SCALE: 1:100


Floor Area:
186.7 m² - 2,010 ft²

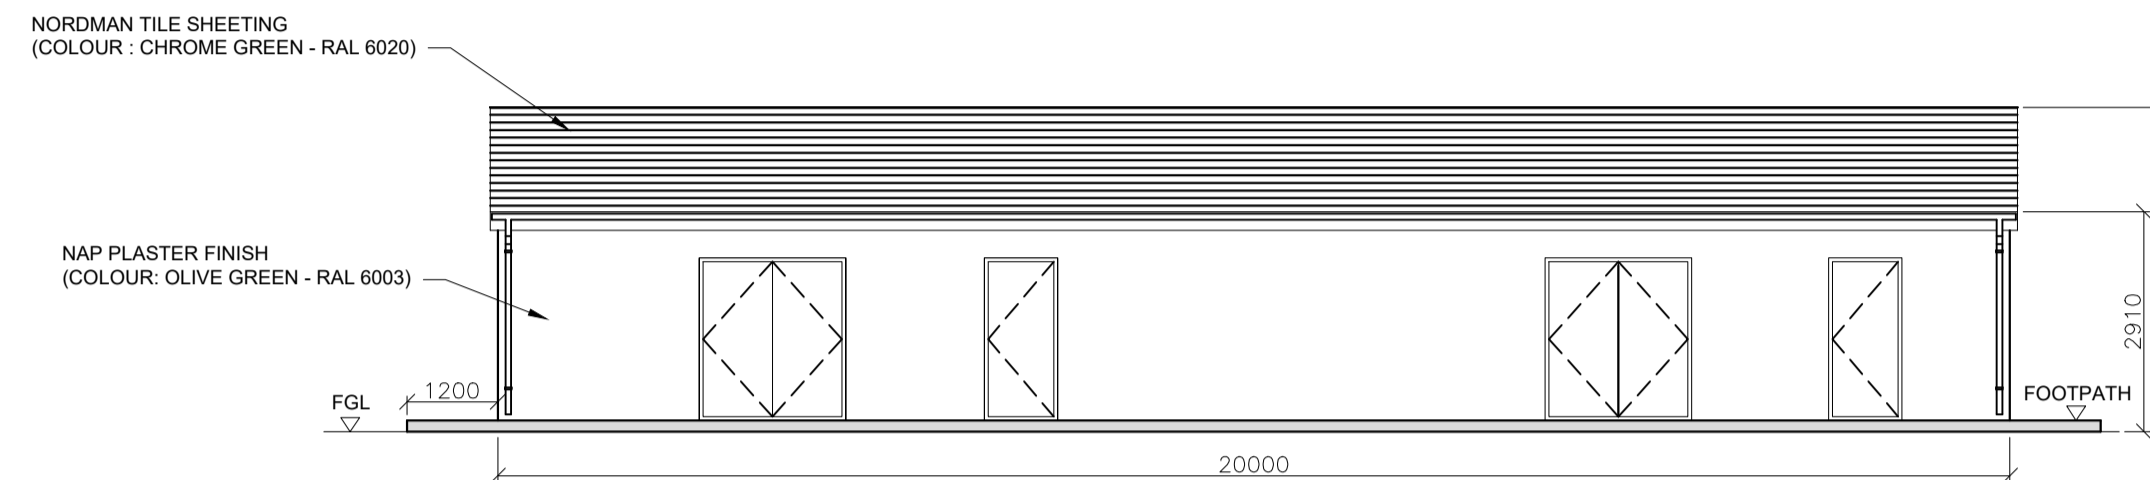


ELEVATION VIEW A
SCALE: 1:100

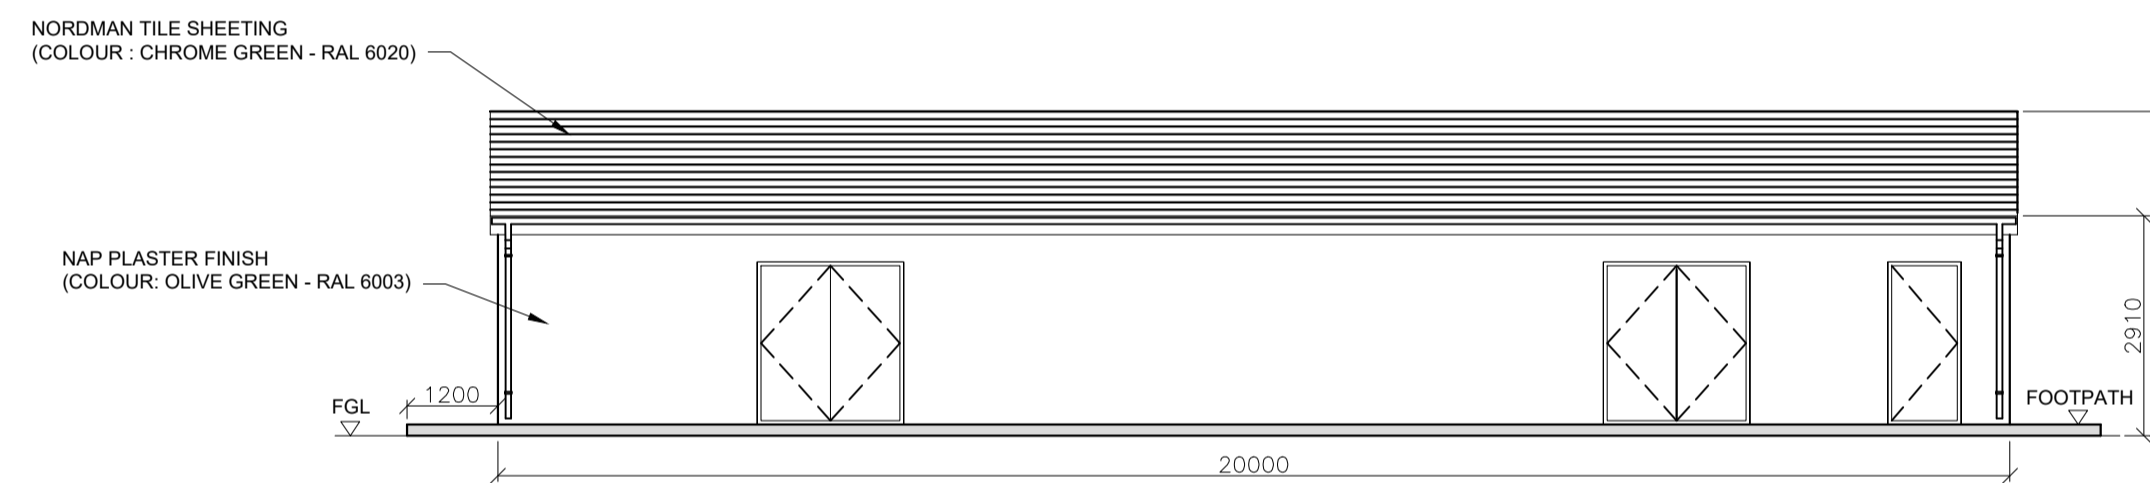


ELEVATION VIEW C
SCALE: 1:100

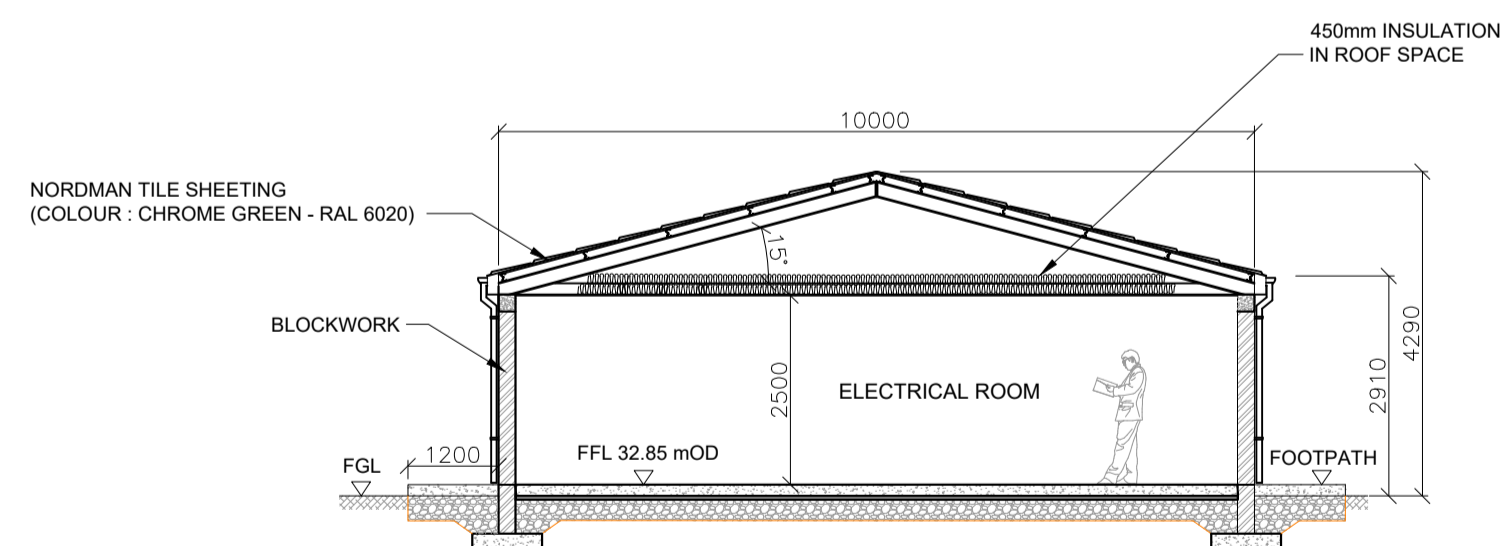

SECTION A-A
SCALE: 1:100

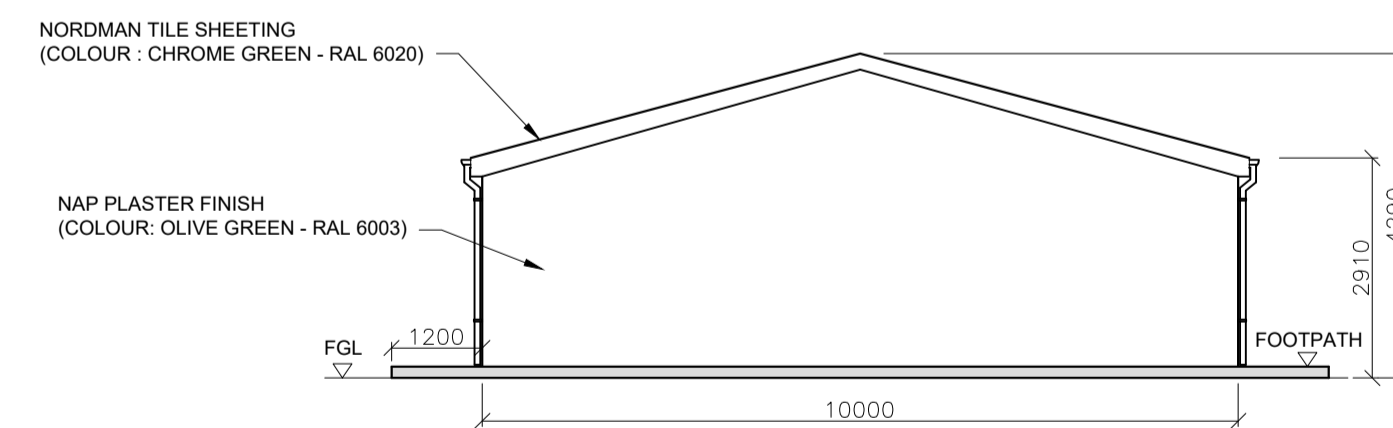

ELEVATION VIEW B
SCALE: 1:100

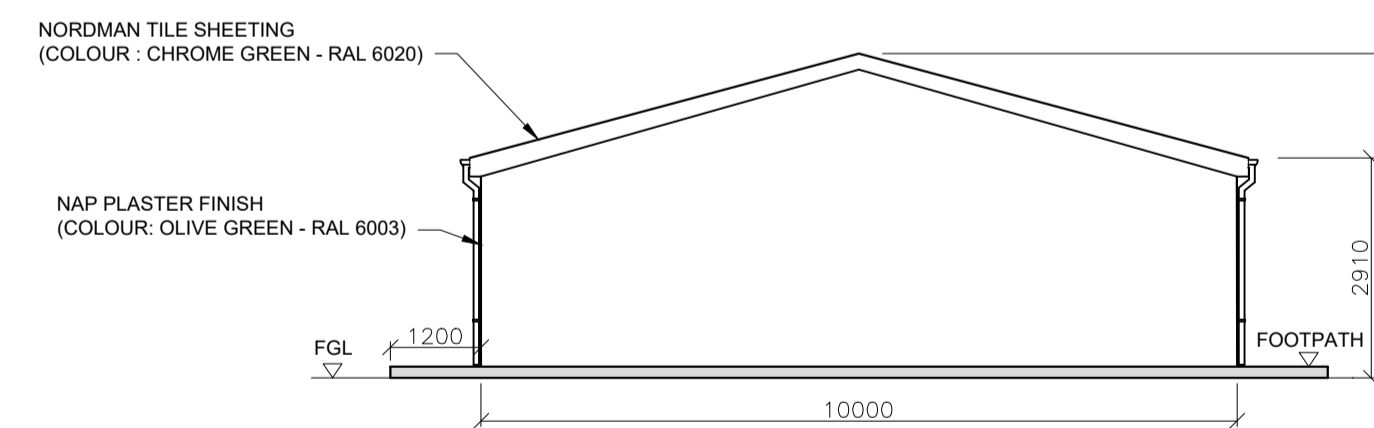

ELEVATION VIEW D
SCALE: 1:100

NOTES

ISSUE FOR PLANNING

Applicant

Shannon LNG Limited

| REV. | DATE | REVISION | BY | CHKD. | APPR. |
|------|----------|--------------------|-----|-------|-------|
| 2 | 11/08/21 | ISSUE FOR PLANNING | RMD | MC | BF |
| 1 | 24/03/21 | ISSUE FOR PLANNING | MAH | MC | BF |
| 0 | 02/10/20 | CONCEPTUAL ISSUE | OC | MC | BF |

Client



GAS NETWORK IRELAND
P.O. BOX 51, Gasworks Road, Cork
Rep of Ireland
T: +353 21 4534000
F: +353 21 4534001

Consultant



Bridge Street Centre
Portlaoise
Co. Laois
R32 W0CC
Ireland
T: (00353)057 866 5400
www.fingleton.ie

Project

SHANNON TECHNOLOGY AND ENERGY PARK (STEP)

Title

**CONTROL & INSTRUMENTATION BUILDING
PLAN, ELEVATIONS & SECTION**

| Drawn | Scale | Drawing Number | Rev. |
|-------------|----------|-----------------|------|
| M.ABOUHJAR | 1:100/A1 | 1227-02-DG-0012 | 2 |
| Checked | Date | Status | |
| M.CONROY | 24/03/21 | ISSUED | |
| Approved | | | |
| B.FINGLETON | | | |